
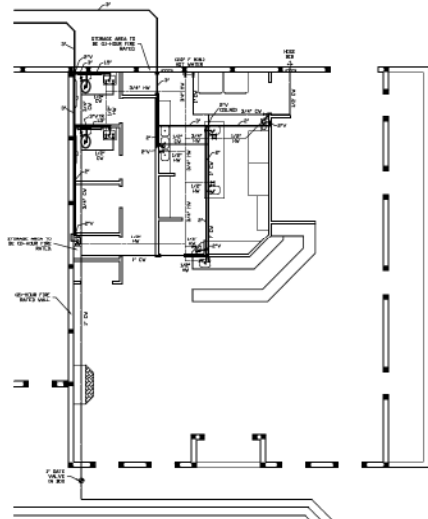
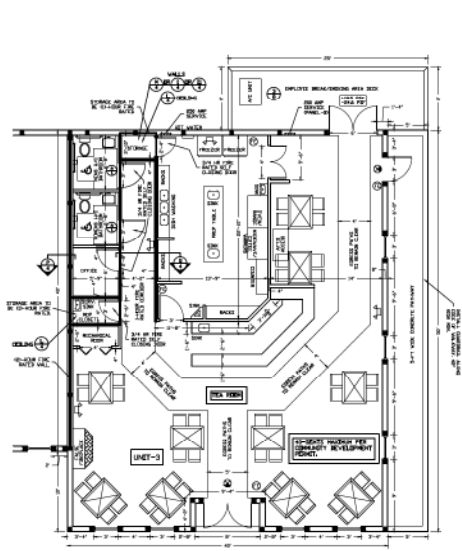


TEA ROOM FLOOR & PLUMBING PLANS

SCALE: N.T.S.

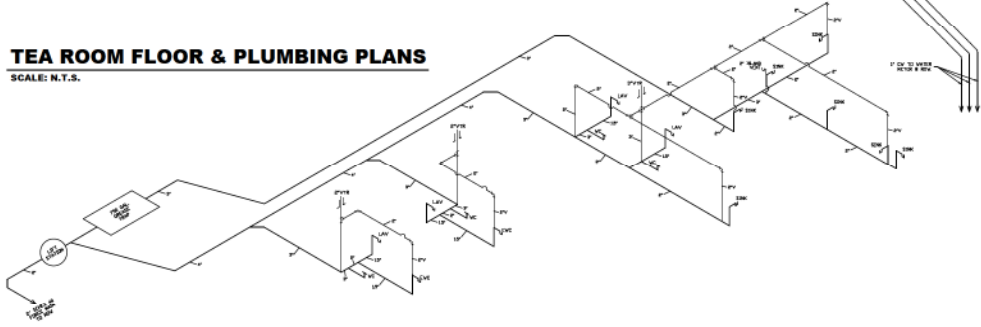

Daniel F. Ardito, P.E.
Florida P.E.#: 56694

SHEET
001
OF
1

JOB NAME
SAMPLE DRAWING
FLORIDA

SHEET TITLE:
TEA ROOM FLOOR
AND PLUMBING PLANS

Daniel F. Ardito, P.E.
FLORIDA P.E.#: 56694
LELAND, FL 34461
CSP-561-4915

DRAWN BY: DA
JOB NAME: HDDE

REVISION:
1. SAMPLE ONLY

DATE:
3/27/23